
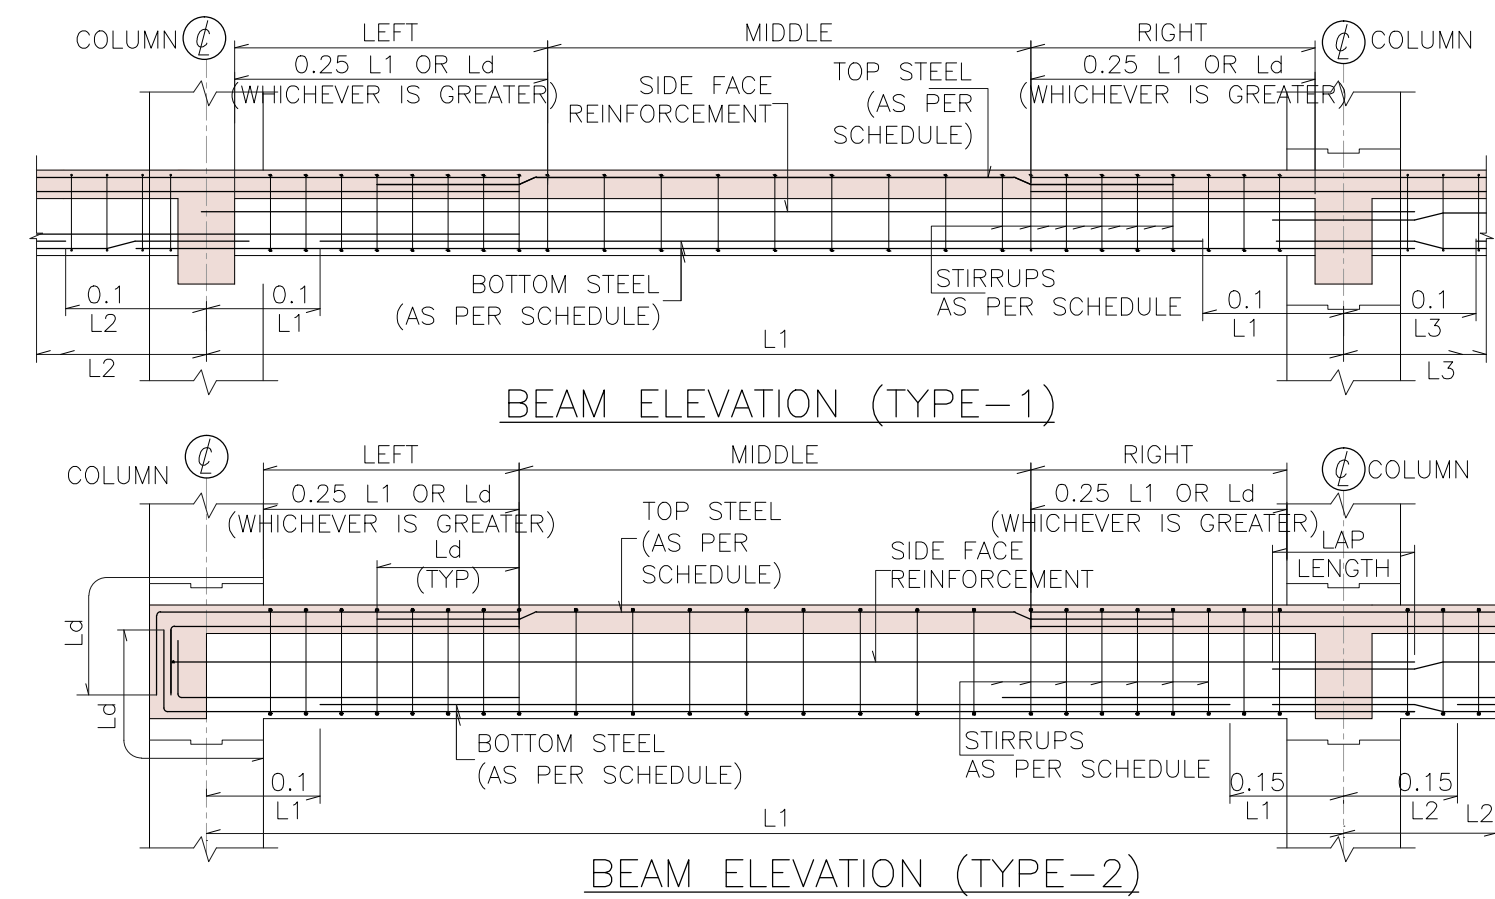
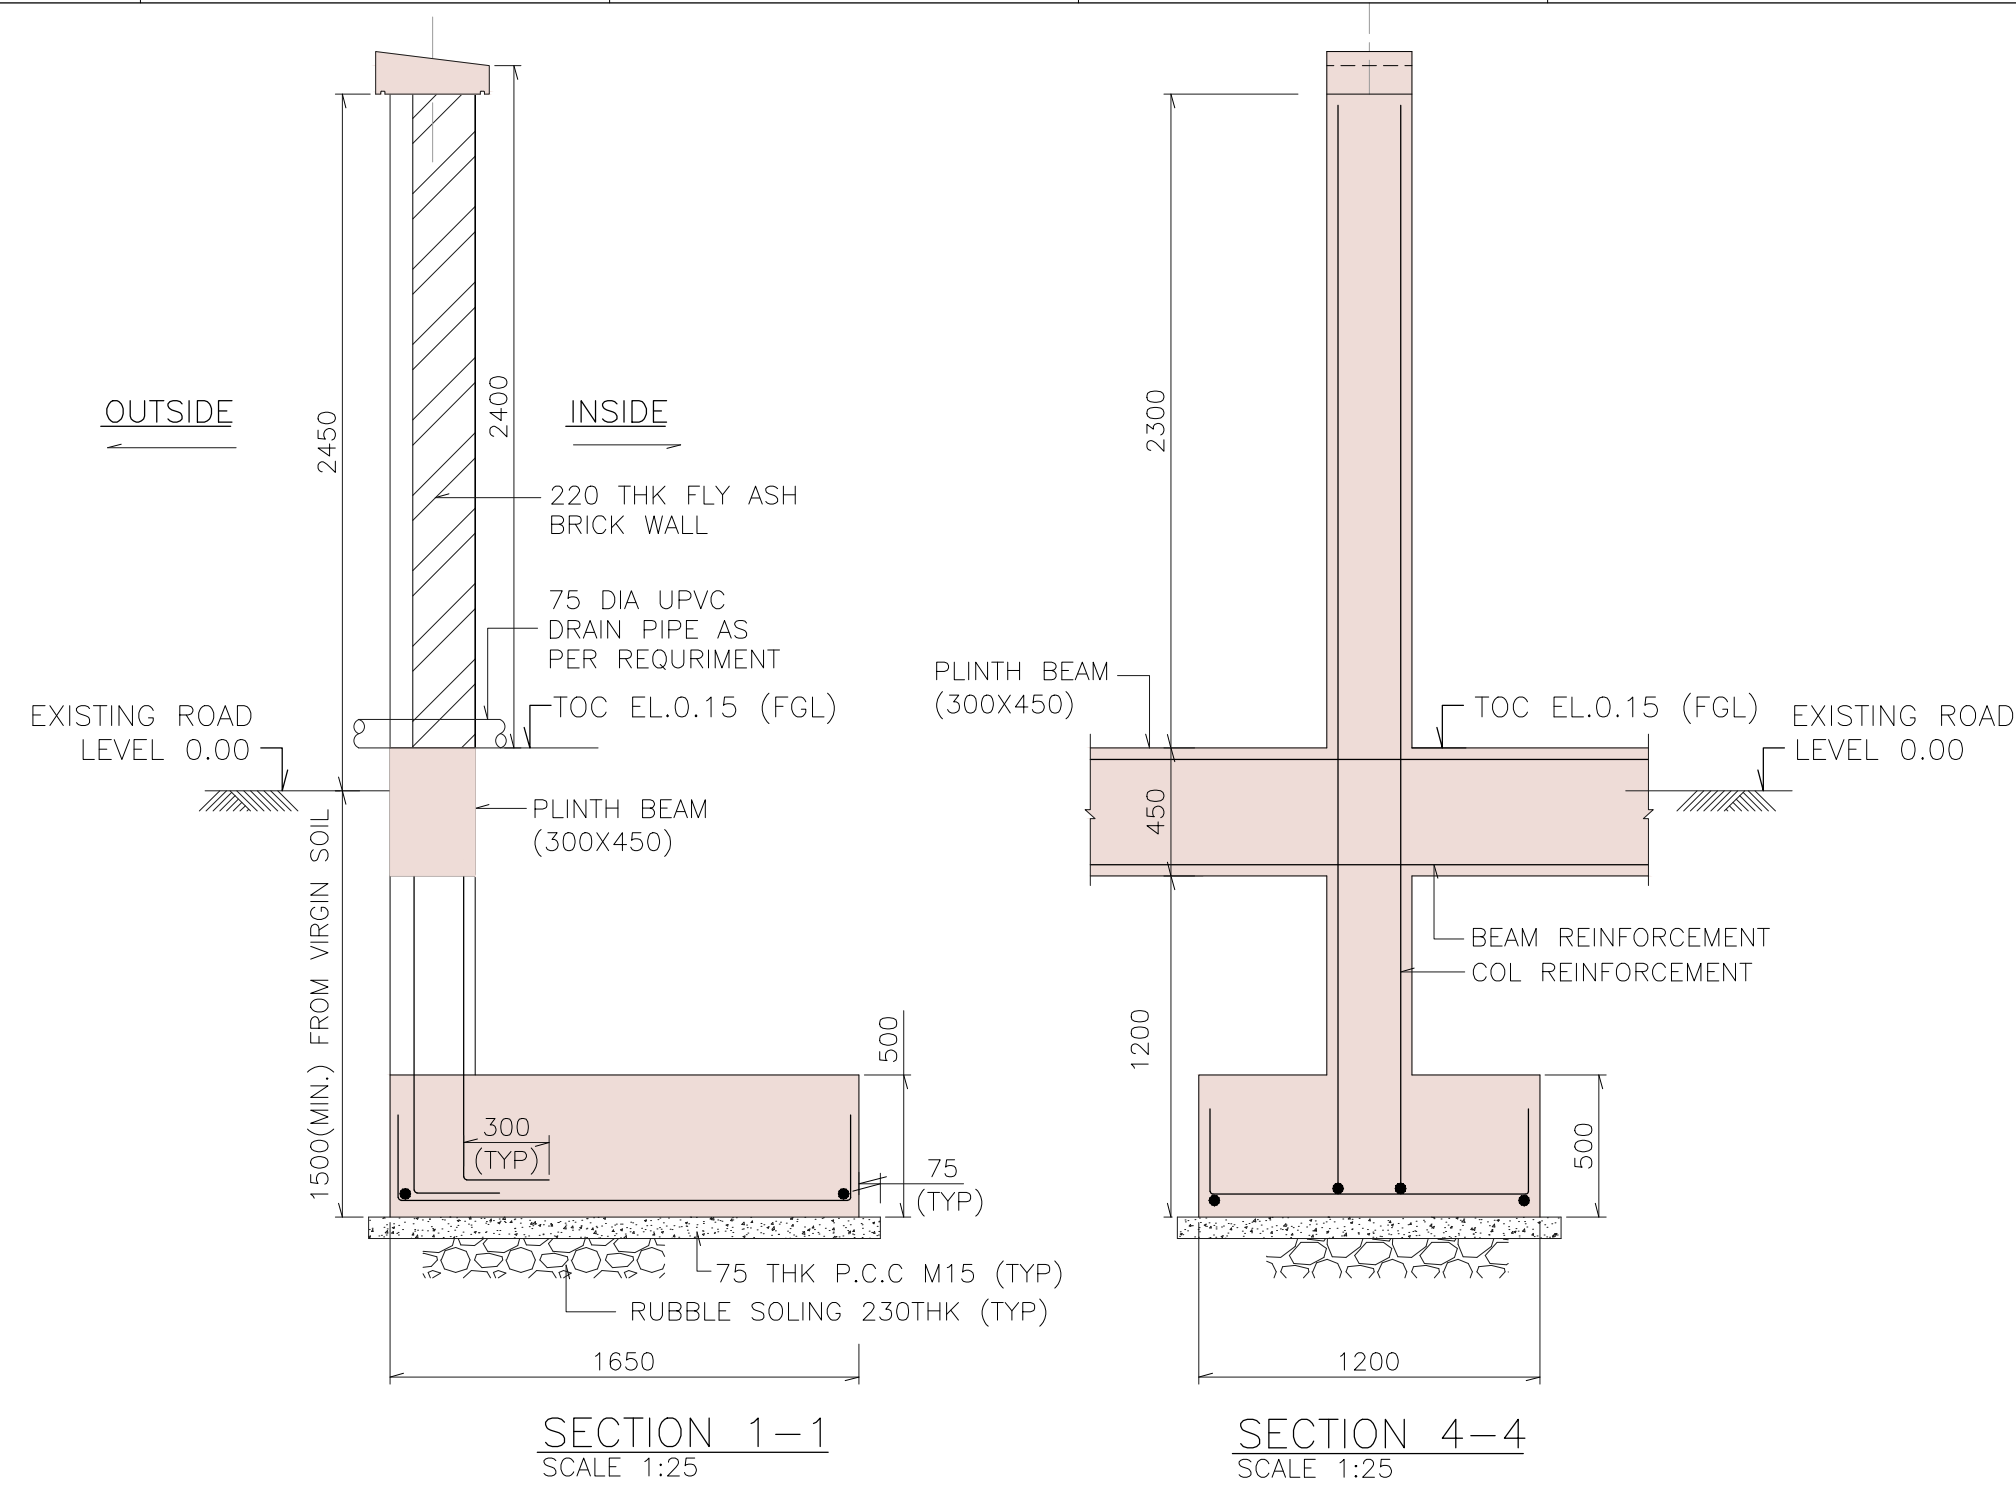


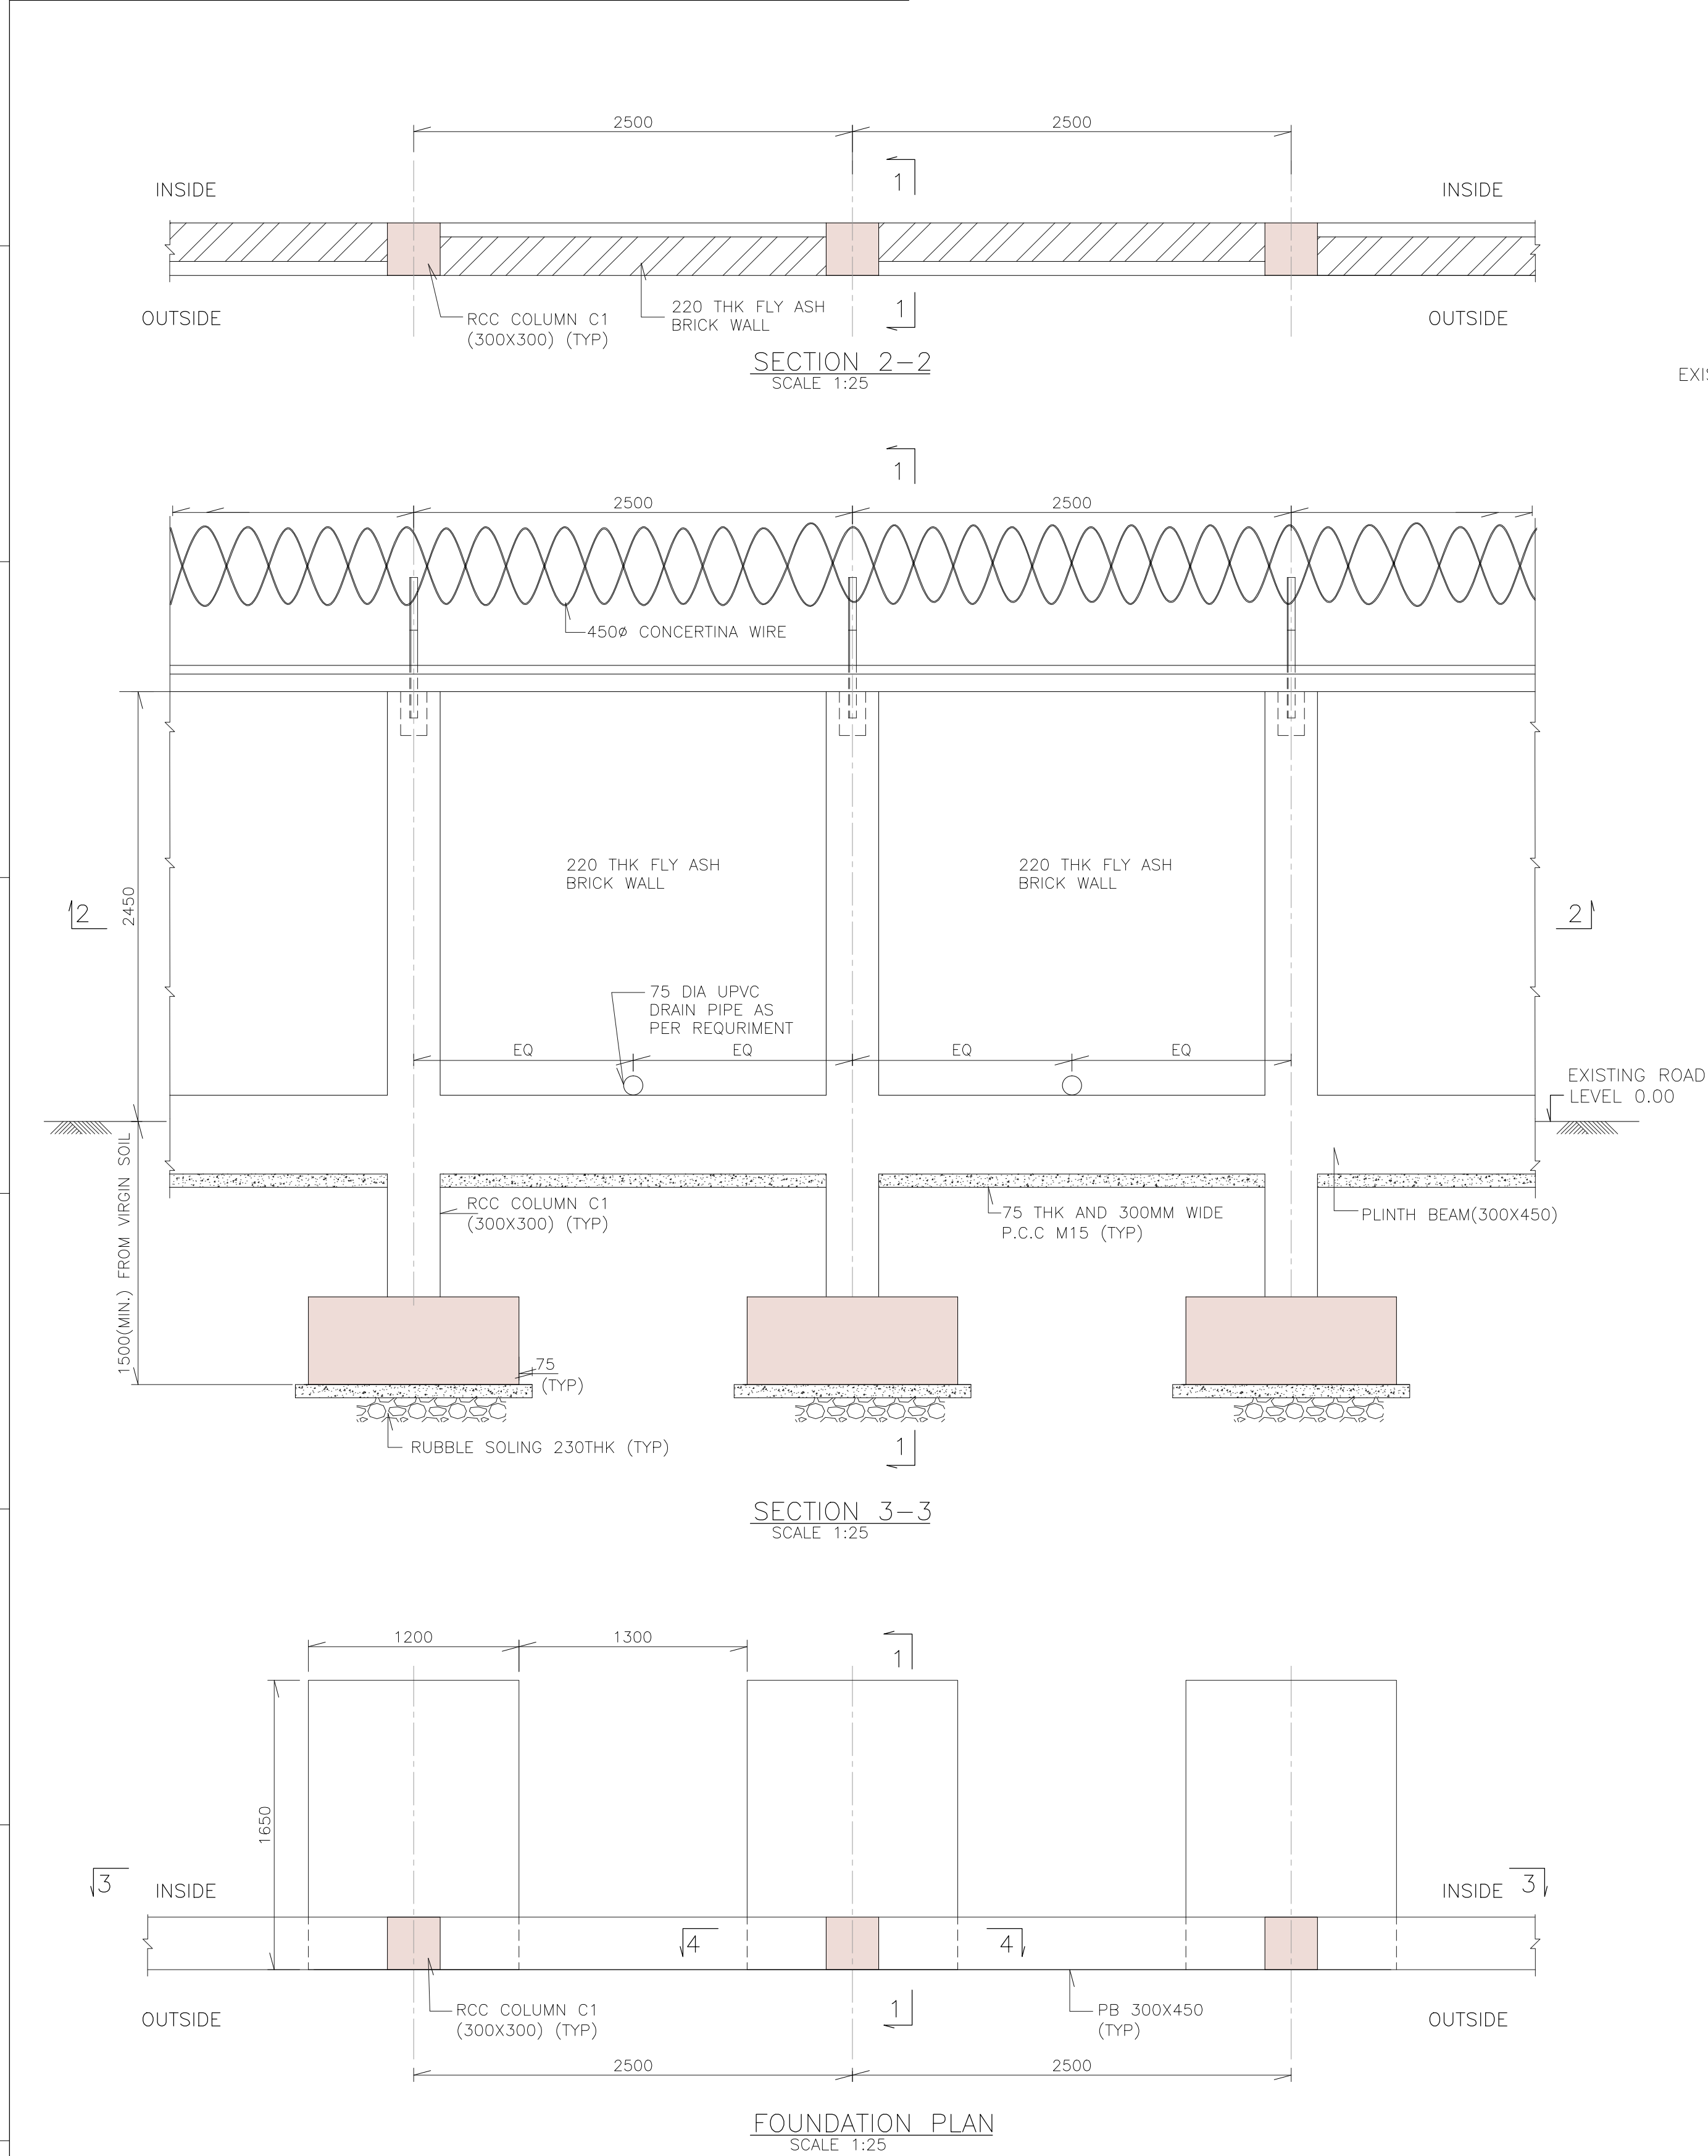

LEGEND:-

GL	GROUND LEVEL
TYP	TYPICAL
THK	THICKNESS
C1	COLUMN
F1	FOOTING
C	CENTER LINE
MIN.	MINIMUM
TOC	TOP OF CONCRETE
EL	ELEVATION
FGL	FINISH GROUND LEVEL
EQ	EQUAL

NOTES:-

ENGINEERING REFERENCE DRAWINGS:-

CONSTRUCTION REFERENCE DRAWING:-

DO NOT SCALE		FOR TENDER	
OFFICE OF THE DEVELOPMENT COMMISSIONER (MSME), MINISTRY OF MICRO, SMALL AND MEDIUM ENTERPRISES, GOVERNMENT OF INDIA			
BOUNDARY WALL DETAILS			
 TATA CONSULTING ENGINEERS LIMITED MUMBAI			
SCALE: AS SHOWN		APPROVED	DATE (RO ISSUE)
DEL.CENTRE-DISC: MUM-CV			DATE (CURRENT ISSUE) 25-01-2016
DRN: SVD			
CHD:		DWG NO TCE.10106A-100-GA-6001	ISSUE P1



[illegible]

FILE NAME : TCE10106AGA6001

'P' (PRELIMINARY) ISSUES ARE NOT TO BE USED FOR CONSTRUCTION / FABRICATION BUT ARE ISSUED FOR LIMITED PURPOSES, ON AS INDICATED IN THE SMALL BLOCK AT THE TOP RIGHT HAND CORNER OF THE TITLE BLOCK.

CONSTRUCTION / FABRICATION WORK PERMITTED ON 'R' (RELEASED) ISSUES ONLY.

INFORMATION CONTAINED WITHIN 'HOLD' IS NOT RELEASED FOR CONSTRUCTION OR FABRICATION. MUST GET DESIGN OFFICE TO CLEAR 'HOLD'S' IN TIME BEFORE PROCEEDING WITH A CONSTRUCTION/FABRICATION WORK RELATIVE TO 'HOLD'S'.

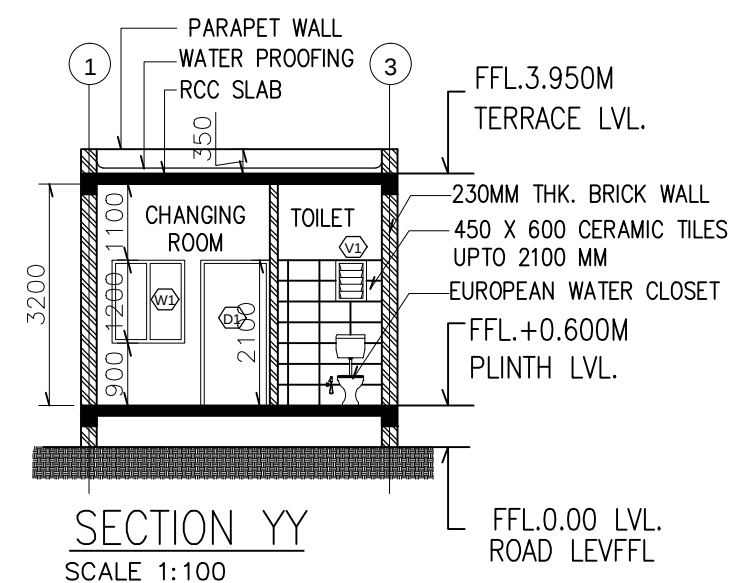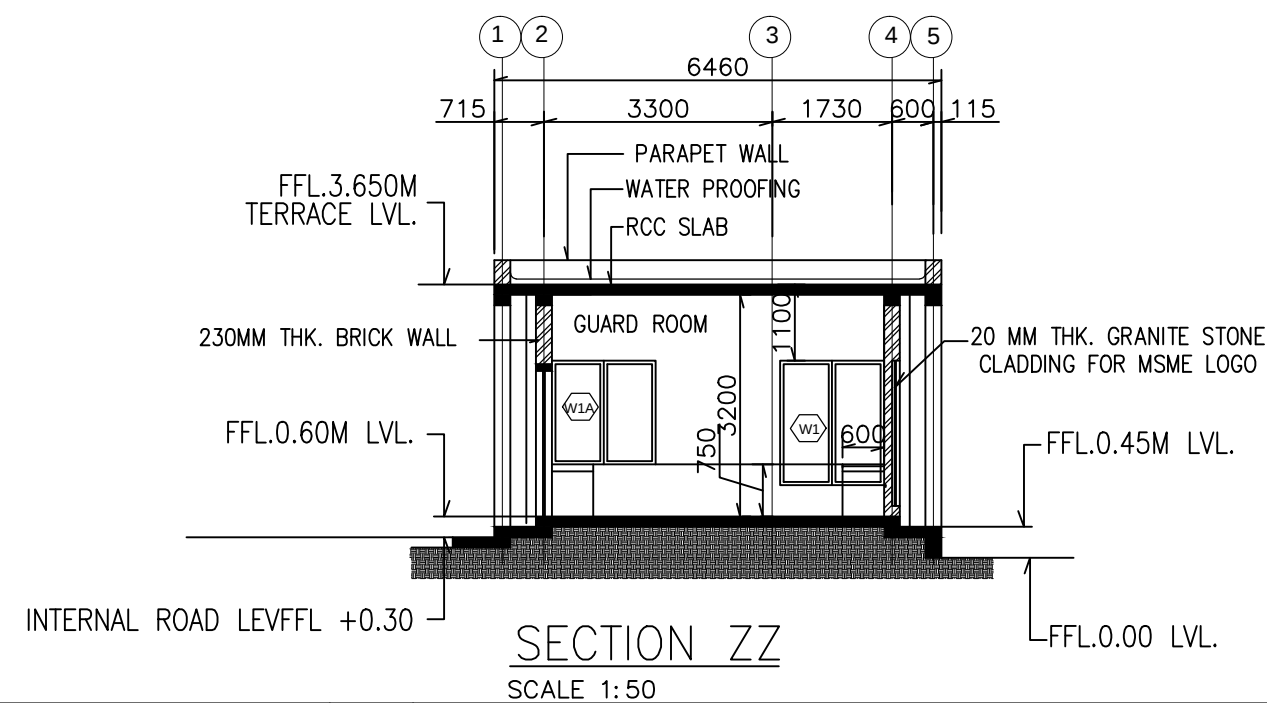


SCHEDULE OF DOORS & WINDOWS			
Item	Size	Description	Nos
D	1000X2100	METAL DOOR FRAMES	3
P1	750X2100	METAL DOOR FRAMES	2
W1	1500X1800	ALUMINIUM WINDOWS (FIXED) WITH TEMPERED GLASS WITH 4 MM SLIT IN GLASS AT BOTTOM	2
W2	1000X1800	ALUMINIUM WINDOWS (FIXED) WITH TEMPERED GLASS WITH 4 MM SLIT IN GLASS AT BOTTOM	2
W1A	1500X1800	ALUMINIUM WINDOWS (OPENABLE) WITH TOUGHENED GLASS	2
W2A	1000X1800	ALUMINIUM WINDOWS (OPENABLE) WITH TOUGHENED GLASS	2
V1	450 X 600	AL VENTILATOR WITH LOUVERS	4

1. ALL DIMENSIONS ARE IN MILLIMETERS AND ELEVATIONS IN METERS UNLESS NOTED OTHERWISE.
2. FFL 0.00 CORRESPONDS TO EXISTING ROAD LEVEL.
3. DO NOT SCALE THE DRAWING
4. ANY DISCREPANCY IN THE DRAWING SHALL BE BROUGHT TO THE IMMEDIATE NOTICE OF ARCHITECT, PRIOR TO EXECUTION OF WORK
5. ALL FLOOR ELEVATIONS MENTIONED ARE FINISHED FLOOR LEVELS
6. REFER SPECIFICATION BEFORE EXECUTION OF ANY ITEM
7. ALL ROAD WORKS/ PAVEMENTS/ HARDSCAPE AS PER RELEVANT DRAWINGS/ DETAILS


1. TCE.10106A-100-AC-5428- PLAN, FFLEVATION & SECTION OF BOUNDARY WALL

DO NOT SCALE		FOR TENDER PURPOSE	
OFFICE OF THE DEVELOPMENT COMMISSIONER (MSME) MINISTRY OF MICRO, SMALL & MEDIUM ENTERPRISES GOVERNMENT OF INDIA.			
GUARD HOUSE – PLAN , ELEVATION & SECTION			
 TATA CONSULTING ENGINEERS LIMITED MUMBAI			
SCALE: AS SHOWN	APPROVED		DATE (RO ISSUE)
DEL.CENTRE-DISC:MUM-AC			DATE (CURRENT ISSUE) 25-01-2016
DRN: SR			
CHD:	DWG NO	TCE.10106A-100-AC-5427	ISSUE P1
TCE FORM NO. 042 RS			

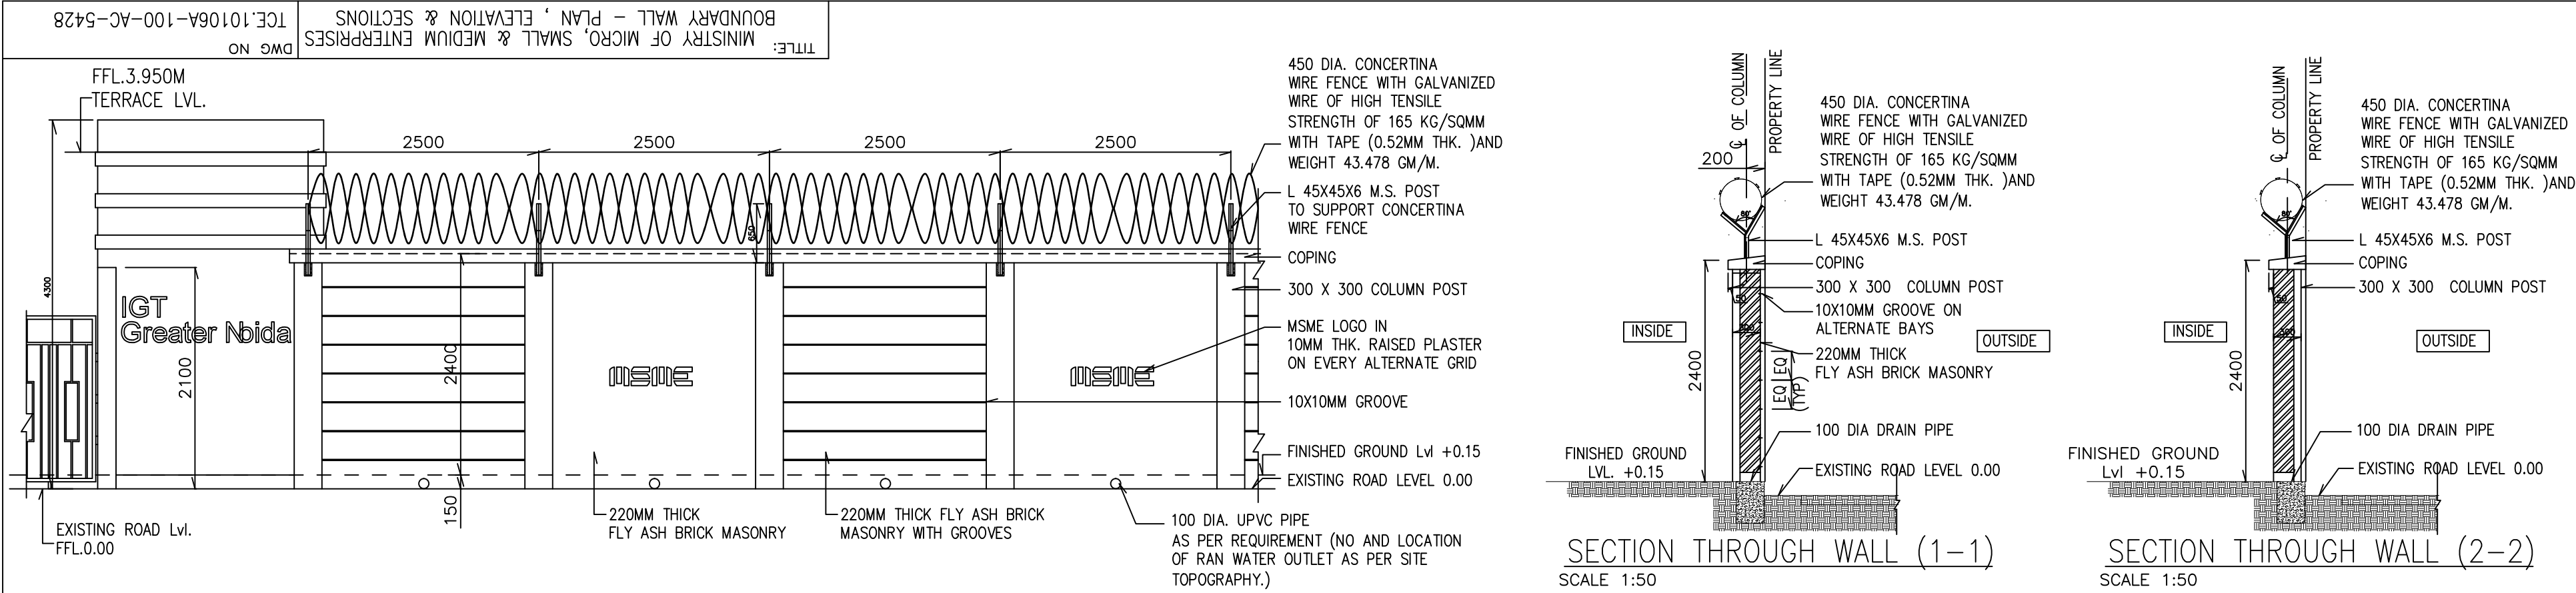



BOUNDARY WALL ELEVATION

SCALE 1:50

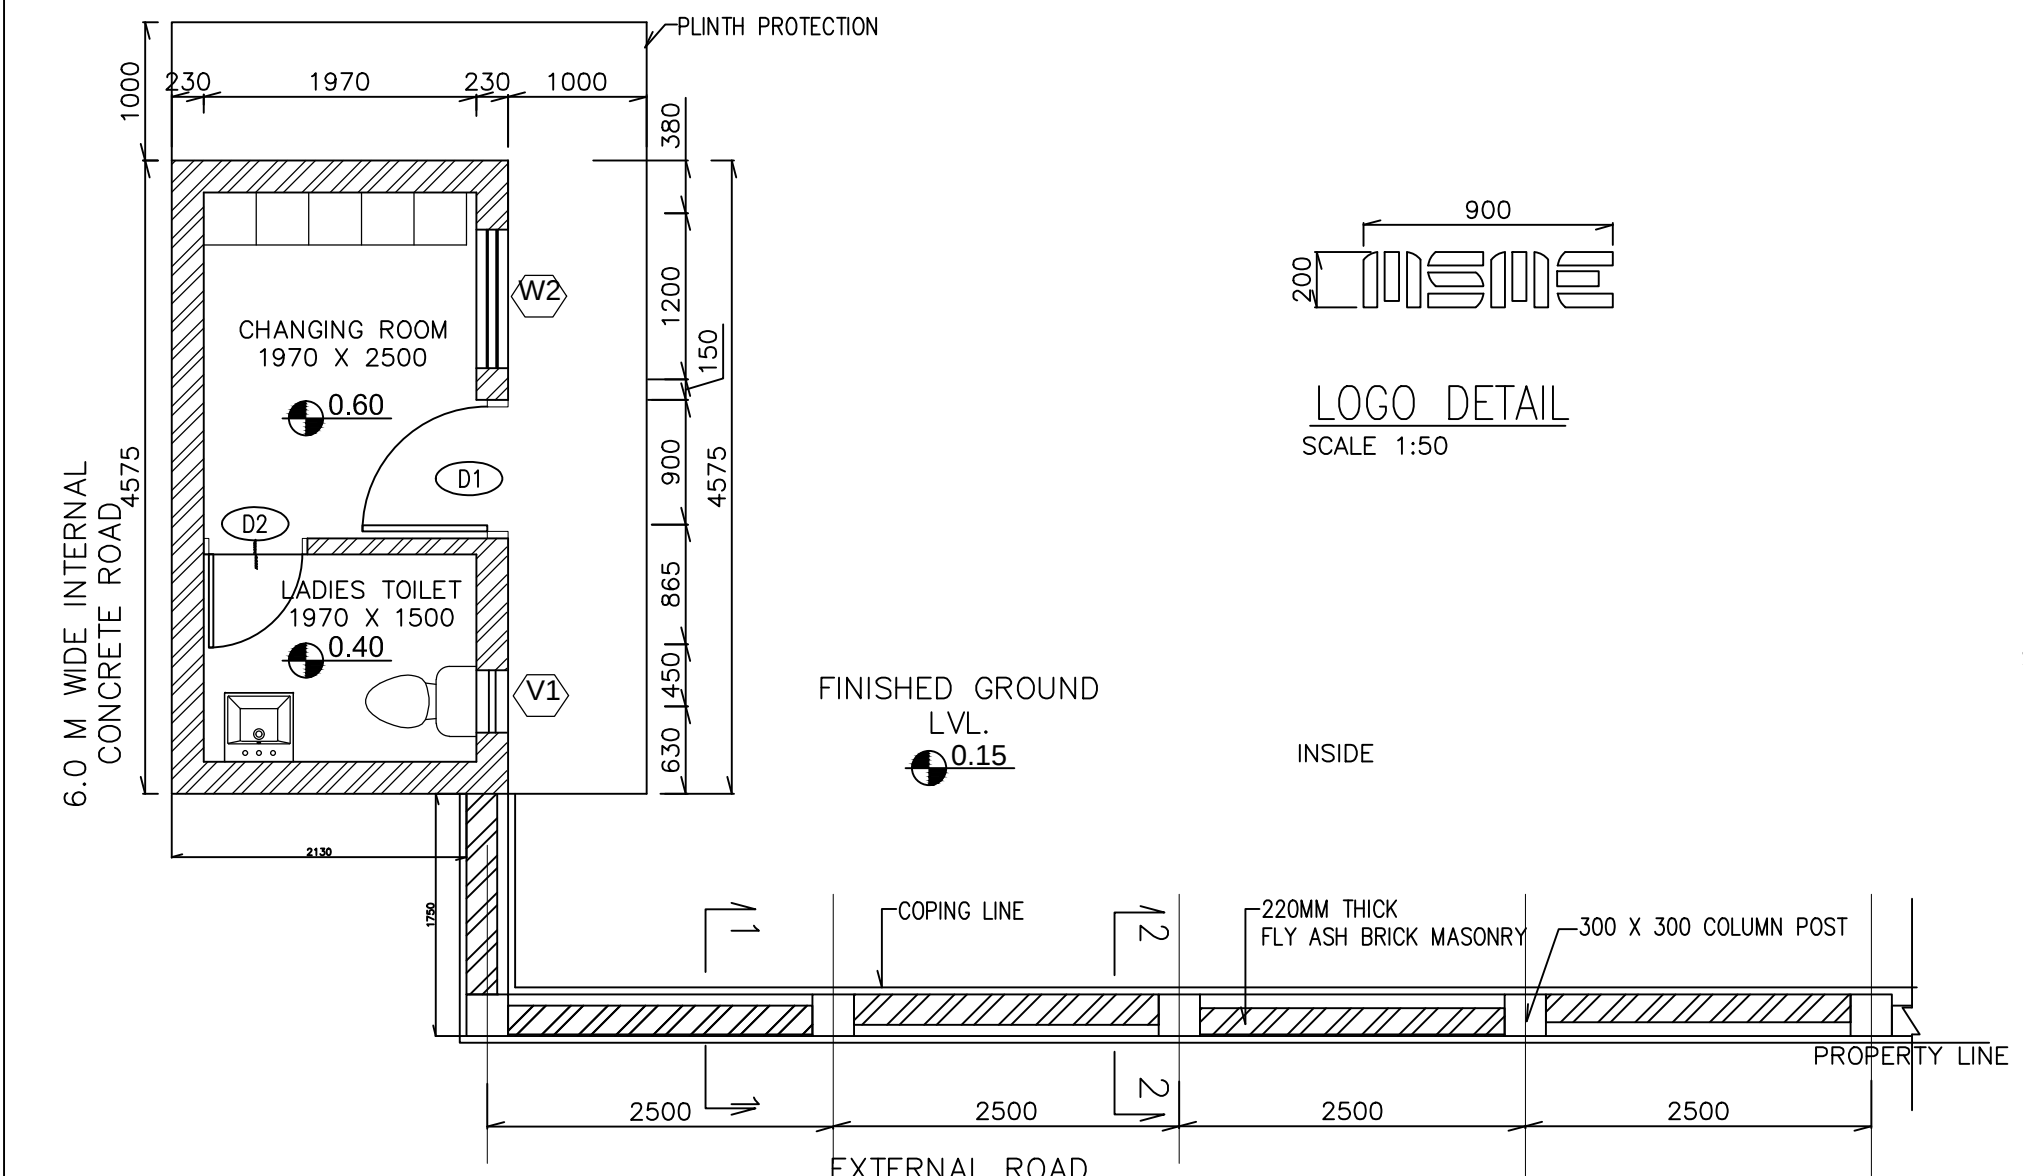

BOUNDARY WALL PLAN

SCALE 1:50

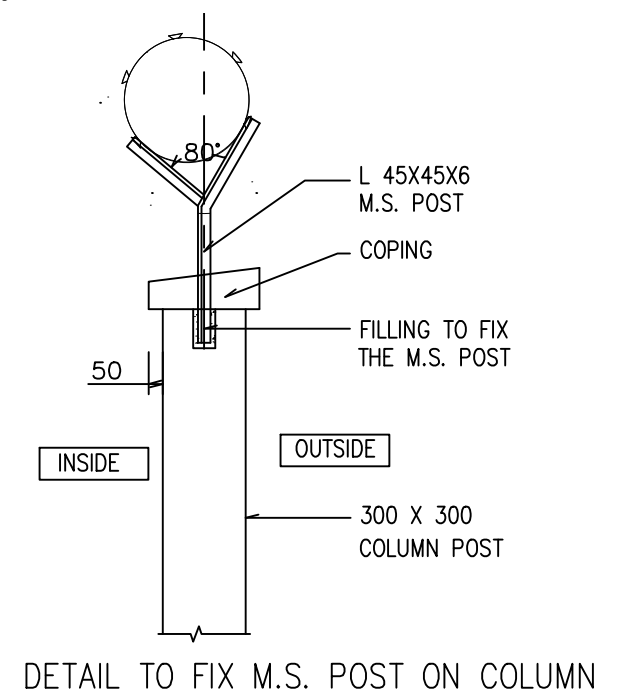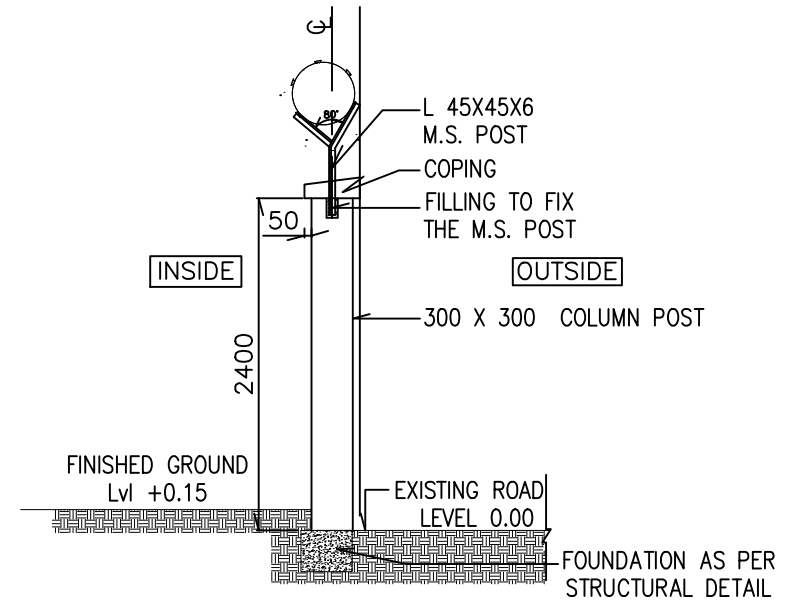

- NOTES
1. ALL DIMENSIONS ARE IN MILIMETERS AND FFLEVELATIONS IN METERS UNLESS NOTED OTHERWISE.
 2. FFL. 0.00 CORRESPONDS TO EXISTING ROAD LEVFFL.
 3. DO NOT SCALE THE DRAWING
 4. ANY DISCREPANCY IN THE DRAWING SHALL BE BROUGHT TO THE IMMEDIATE NOTICE OF ARCHITECT, PRIOR TO EXECUTION OF WORK
 5. ALL FLOOR FFLEVELATIONS MENTIONED ARE FINISHED FLOOR LEVFFLS
 6. GROOVES ON ALTERNATE PANFFLS TO BE FILLED WITH CEMENT MORTAR TO ACHIEVE THE DESIGN AS SHOWN AND BOUNDARY WALL TO BE PAINTED WITH EXTERIOR GRADE PAINT.
 7. REFER SPECIFICATION BEFORE EXECUTION OF ANY ITEM
 8. FGL AS PER SITE TOPOGRAPHY.

REFERENCE DRAWING

1. TCE.10106A-100-AC-5427- PLAN, FFLEVELATION & SECTION OF GUARD HOUSE

ENGINEERING REFERENCE DRAWING

DO NOT SCALE FOR TENDER PURPOSE

OFFICE OF THE DEVELOPMENT COMMISSIONER (MSME)
MINISTRY OF MICRO, SMALL & MEDIUM ENTERPRISES
GOVERNMENT OF INDIA.

BOUNDARY WALL - PLAN , ELEVATION & SECTION

TATA CONSULTING ENGINEERS LIMITED
MUMBAI

SCALE: AS SHOWN	APPROVED	DATE (RO ISSUE)
DEL.CENTRE-DISC:MUM-AC		DATE (CURRENT ISSUE) 25-01-2016
DRN: SR		
CHD:	DWG NO TCE.10106A-100-AC-5428	ISSUE P1

FOR RO ISSUE ONLY			ISSUE	REVISIONS	DRN	CLEARED					APPD	DATE	FILE NAME : TCE.10106AAC5428
DISC.	SIGNATURE	DATE				CIVIL	ELEC	I&C	MECH				
CIVIL													"P" (PRELIMINARY) ISSUES ARE NOT TO BE USED FOR CONSTRUCTION / FABRICATION BUT ARE ISSUED FOR LIMITED PURPOSES ONLY AS INDICATED IN THE SMALL BLOCK AT THE TOP RIGHT HAND CORNER OF THE TITLE BLOCK. CONSTRUCTION / FABRICATION WORK IS PERMITTED ON "R" (RELEASED) ISSUES ONLY. INFORMATION CONTAINED WITHIN "HOLD" IS NOT RELEASED FOR CONSTRUCTION/ FABRICATION. FIELD MUST GET DESIGN OFFICE TO CLEAR "HOLDS" IN TIME BEFORE PROCEEDING WITH ANY CONSTRUCTION/FABRICATION WORK RELATED TO "HOLDS".
ELEC													
I&C													
MECH													




GATE PANEL DETAIL


1. ALL DIMENSIONS ARE IN MILLIMETERS AND ELEVATIONS IN METERS UNLESS NOTED OTHERWISE.
2. EL. 0.00 CORRESPONDS TO EXISTING ROAD LEVEL.
3. DO NOT SCALE THE DRAWING
4. ANY DISCREPANCY IN THE DRAWING SHALL BE BROUGHT TO THE IMMEDIATE NOTICE OF ARCHITECT, PRIOR TO EXECUTION OF WORK
5. ALL FLOOR ELEVATIONS MENTIONED ARE FINISHED FLOOR LEVELS
6. REFER SPECIFICATION BEFORE EXECUTION OF ANY ITEM
7. ALL MS WORKS TO BE APPLIED WITH ZINC EPOXY PRIMER AND FINISHED WITH METALLIC PAINT AS PER DETAIL SPECIFICATIONS

1. TCE.10106A-100-AC-5427- PLAN, FFLEVATION &
SECTION OF GUARD HOUSE
2. TCE.10106A-100-AC-5428- PLAN, FFLEVATION &
SECTION OF BOUNDARY WALL


FILE NAME: F-042-Rev-R5.dwg

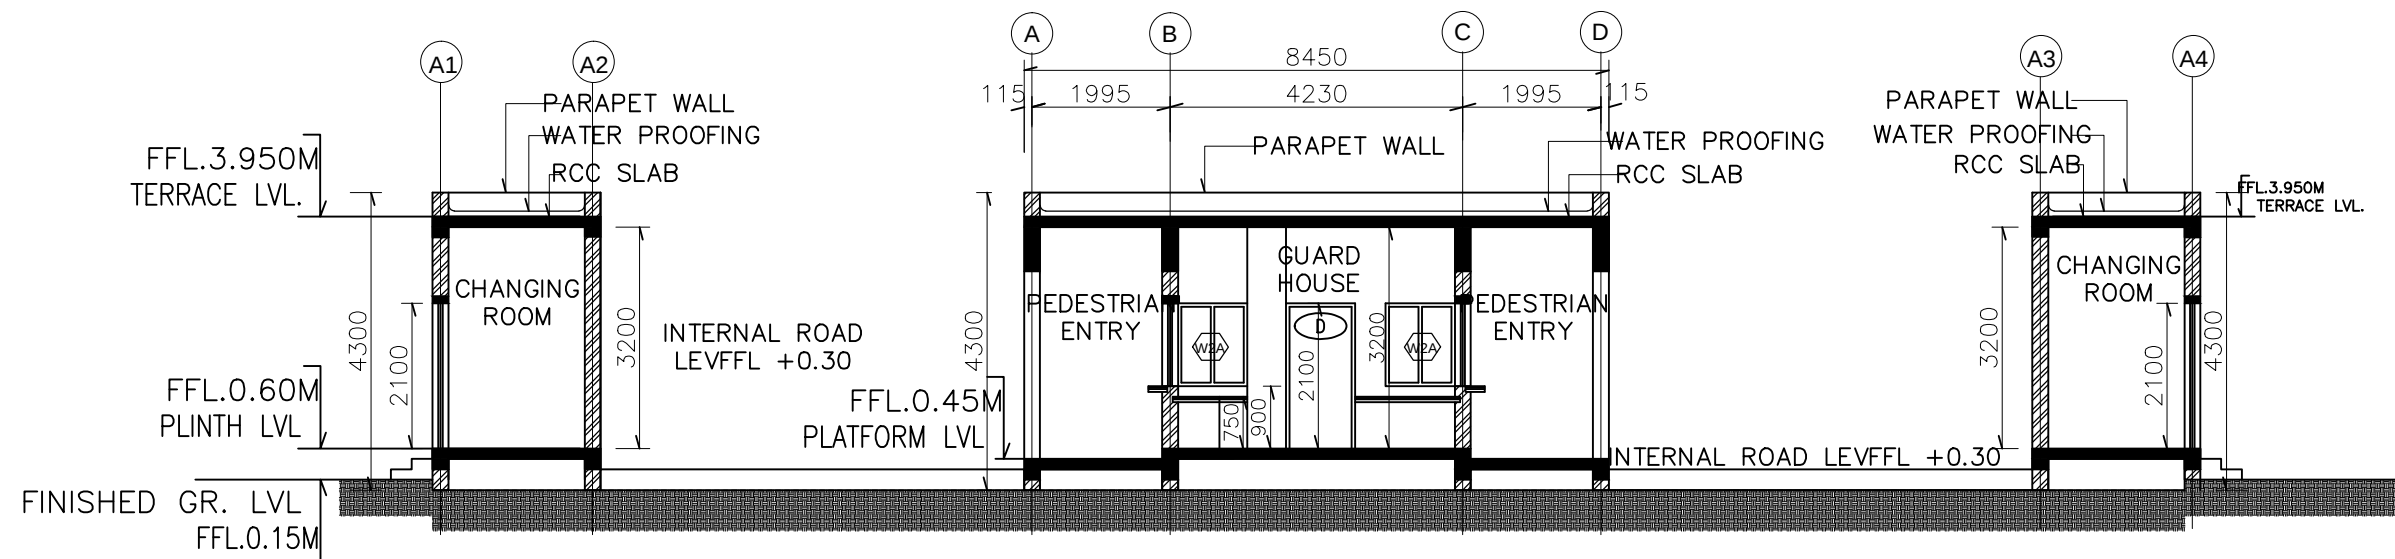


SECTION XX
SCALE 1:100

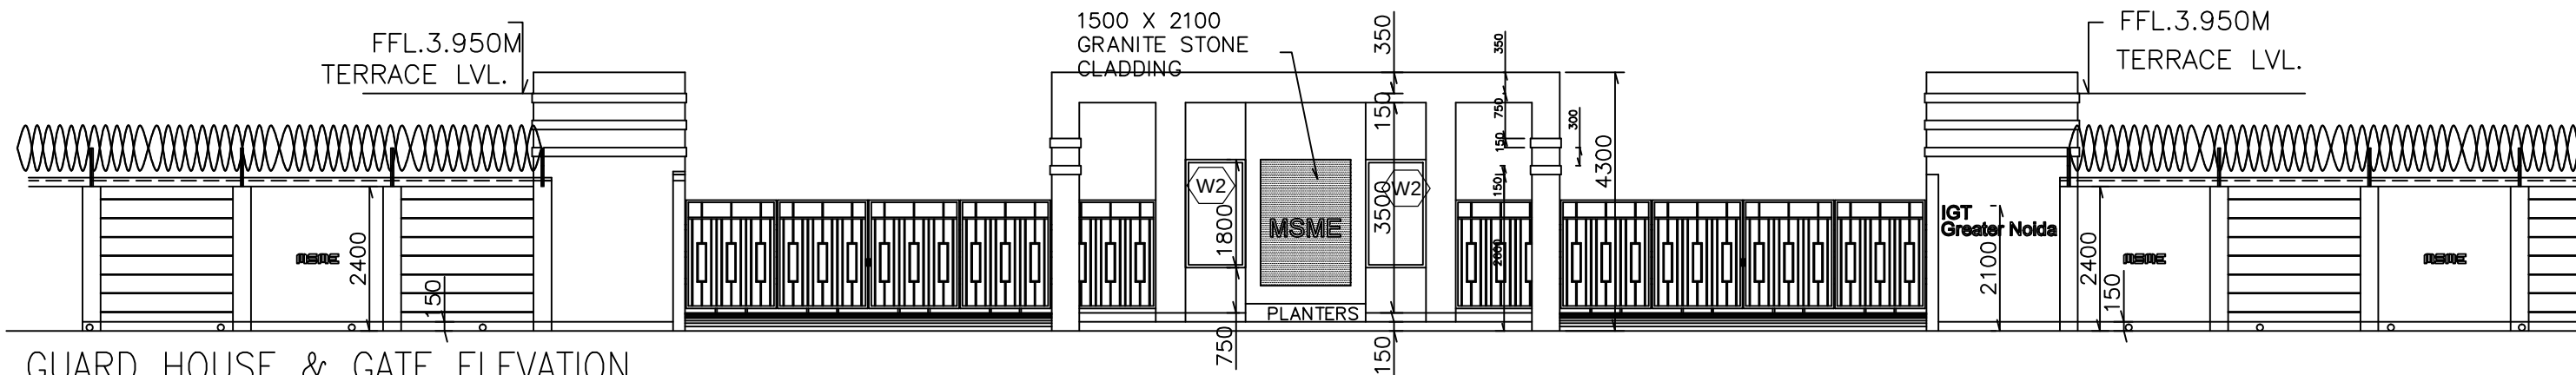

GUARD HOUSE & GATE ELEVATION
SCALE 1:100

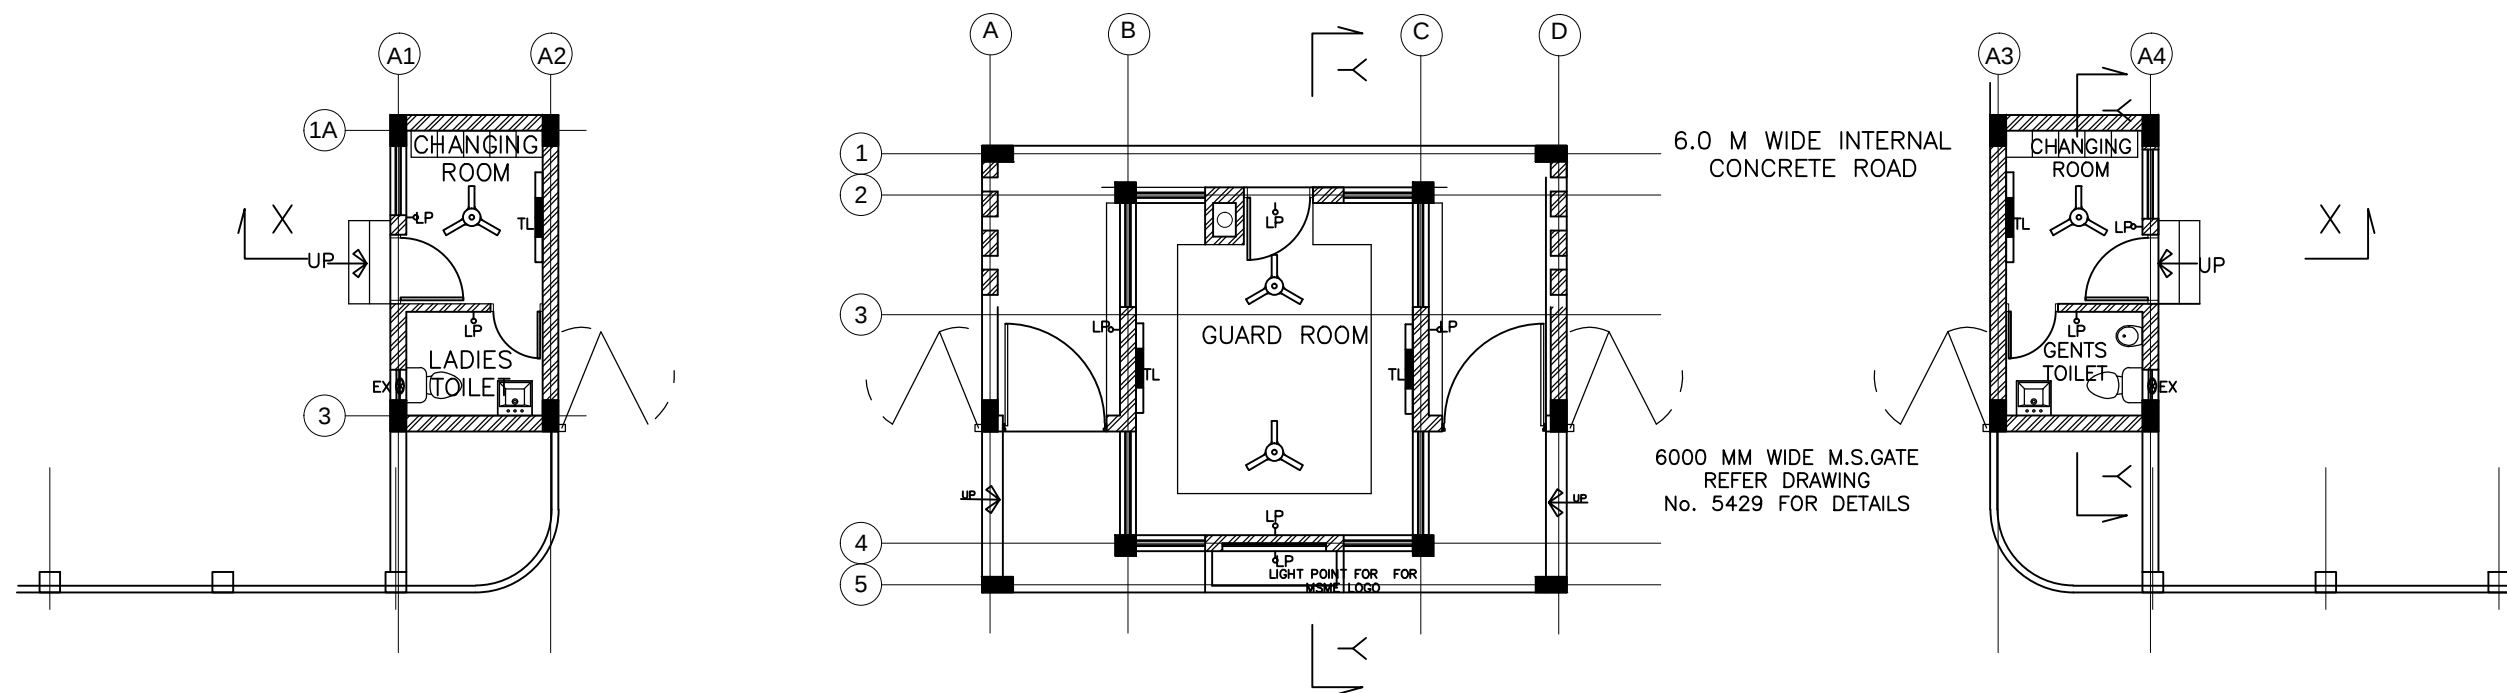

LIGHTING LAYOUT - GUARD HOUSE & GATE PLAN
SCALE 1:100

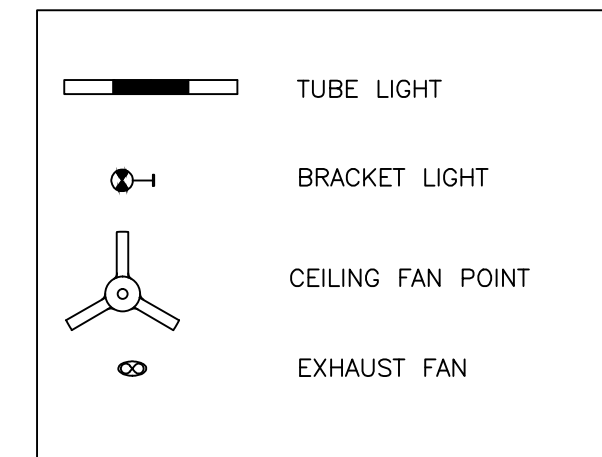

DO NOT SCALE FOR TENDER PURPOSE

OFFICE OF THE DEVELOPMENT COMMISSIONER (MSME)
MINISTRY OF MICRO, SMALL & MEDIUM ENTERPRISES
GOVERNMENT OF INDIA.

GUARD BLOCK- ELEVATION & SECTION

TATA CONSULTING ENGINEERS LIMITED
MUMBAI

SCALE: AS SHOWN APPROVED DATE (RO ISSUE)
DEL.CENTRE-DISC:MUM-AC DATE (CURRENT ISSUE)
25-01-2016
DRN: SR
CHD: DWG NO TCE.10106A-100-AC-5430 ISSUE P1

FOR RO ISSUE ONLY			ISSUE	REVISIONS	DRN	CLEARED				APPD	DATE	FILE NAME : TCE.10106AAC5430
DISC.	SIGNATURE	DATE				CIVIL	ELEC	I&C	MECH			
CIVIL												"P" (PRELIMINARY) ISSUES ARE NOT TO BE USED FOR CONSTRUCTION / FABRICATION BUT ARE ISSUED FOR LIMITED PURPOSES ONLY AS INDICATED IN THE SMALL BLOCK AT THE TOP RIGHT HAND CORNER OF THE TITLE BLOCK. CONSTRUCTION / FABRICATION WORK IS PERMITTED ON "R" (RELEASED) ISSUES ONLY. INFORMATION CONTAINED WITHIN "HOLD" IS NOT RELEASED FOR CONSTRUCTION / FABRICATION. FIELD MUST GET DESIGN OFFICE TO CLEAR "HOLD" IN TIME BEFORE PROCEEDING WITH ANY CONSTRUCTION / FABRICATION WORK RELATED TO "HOLD".
ELEC												
I&C												
MECH												

FILE NAME: F-042-Rev-R5.dwg

TCE FORM NO. 042 R5

25-01-2016